

 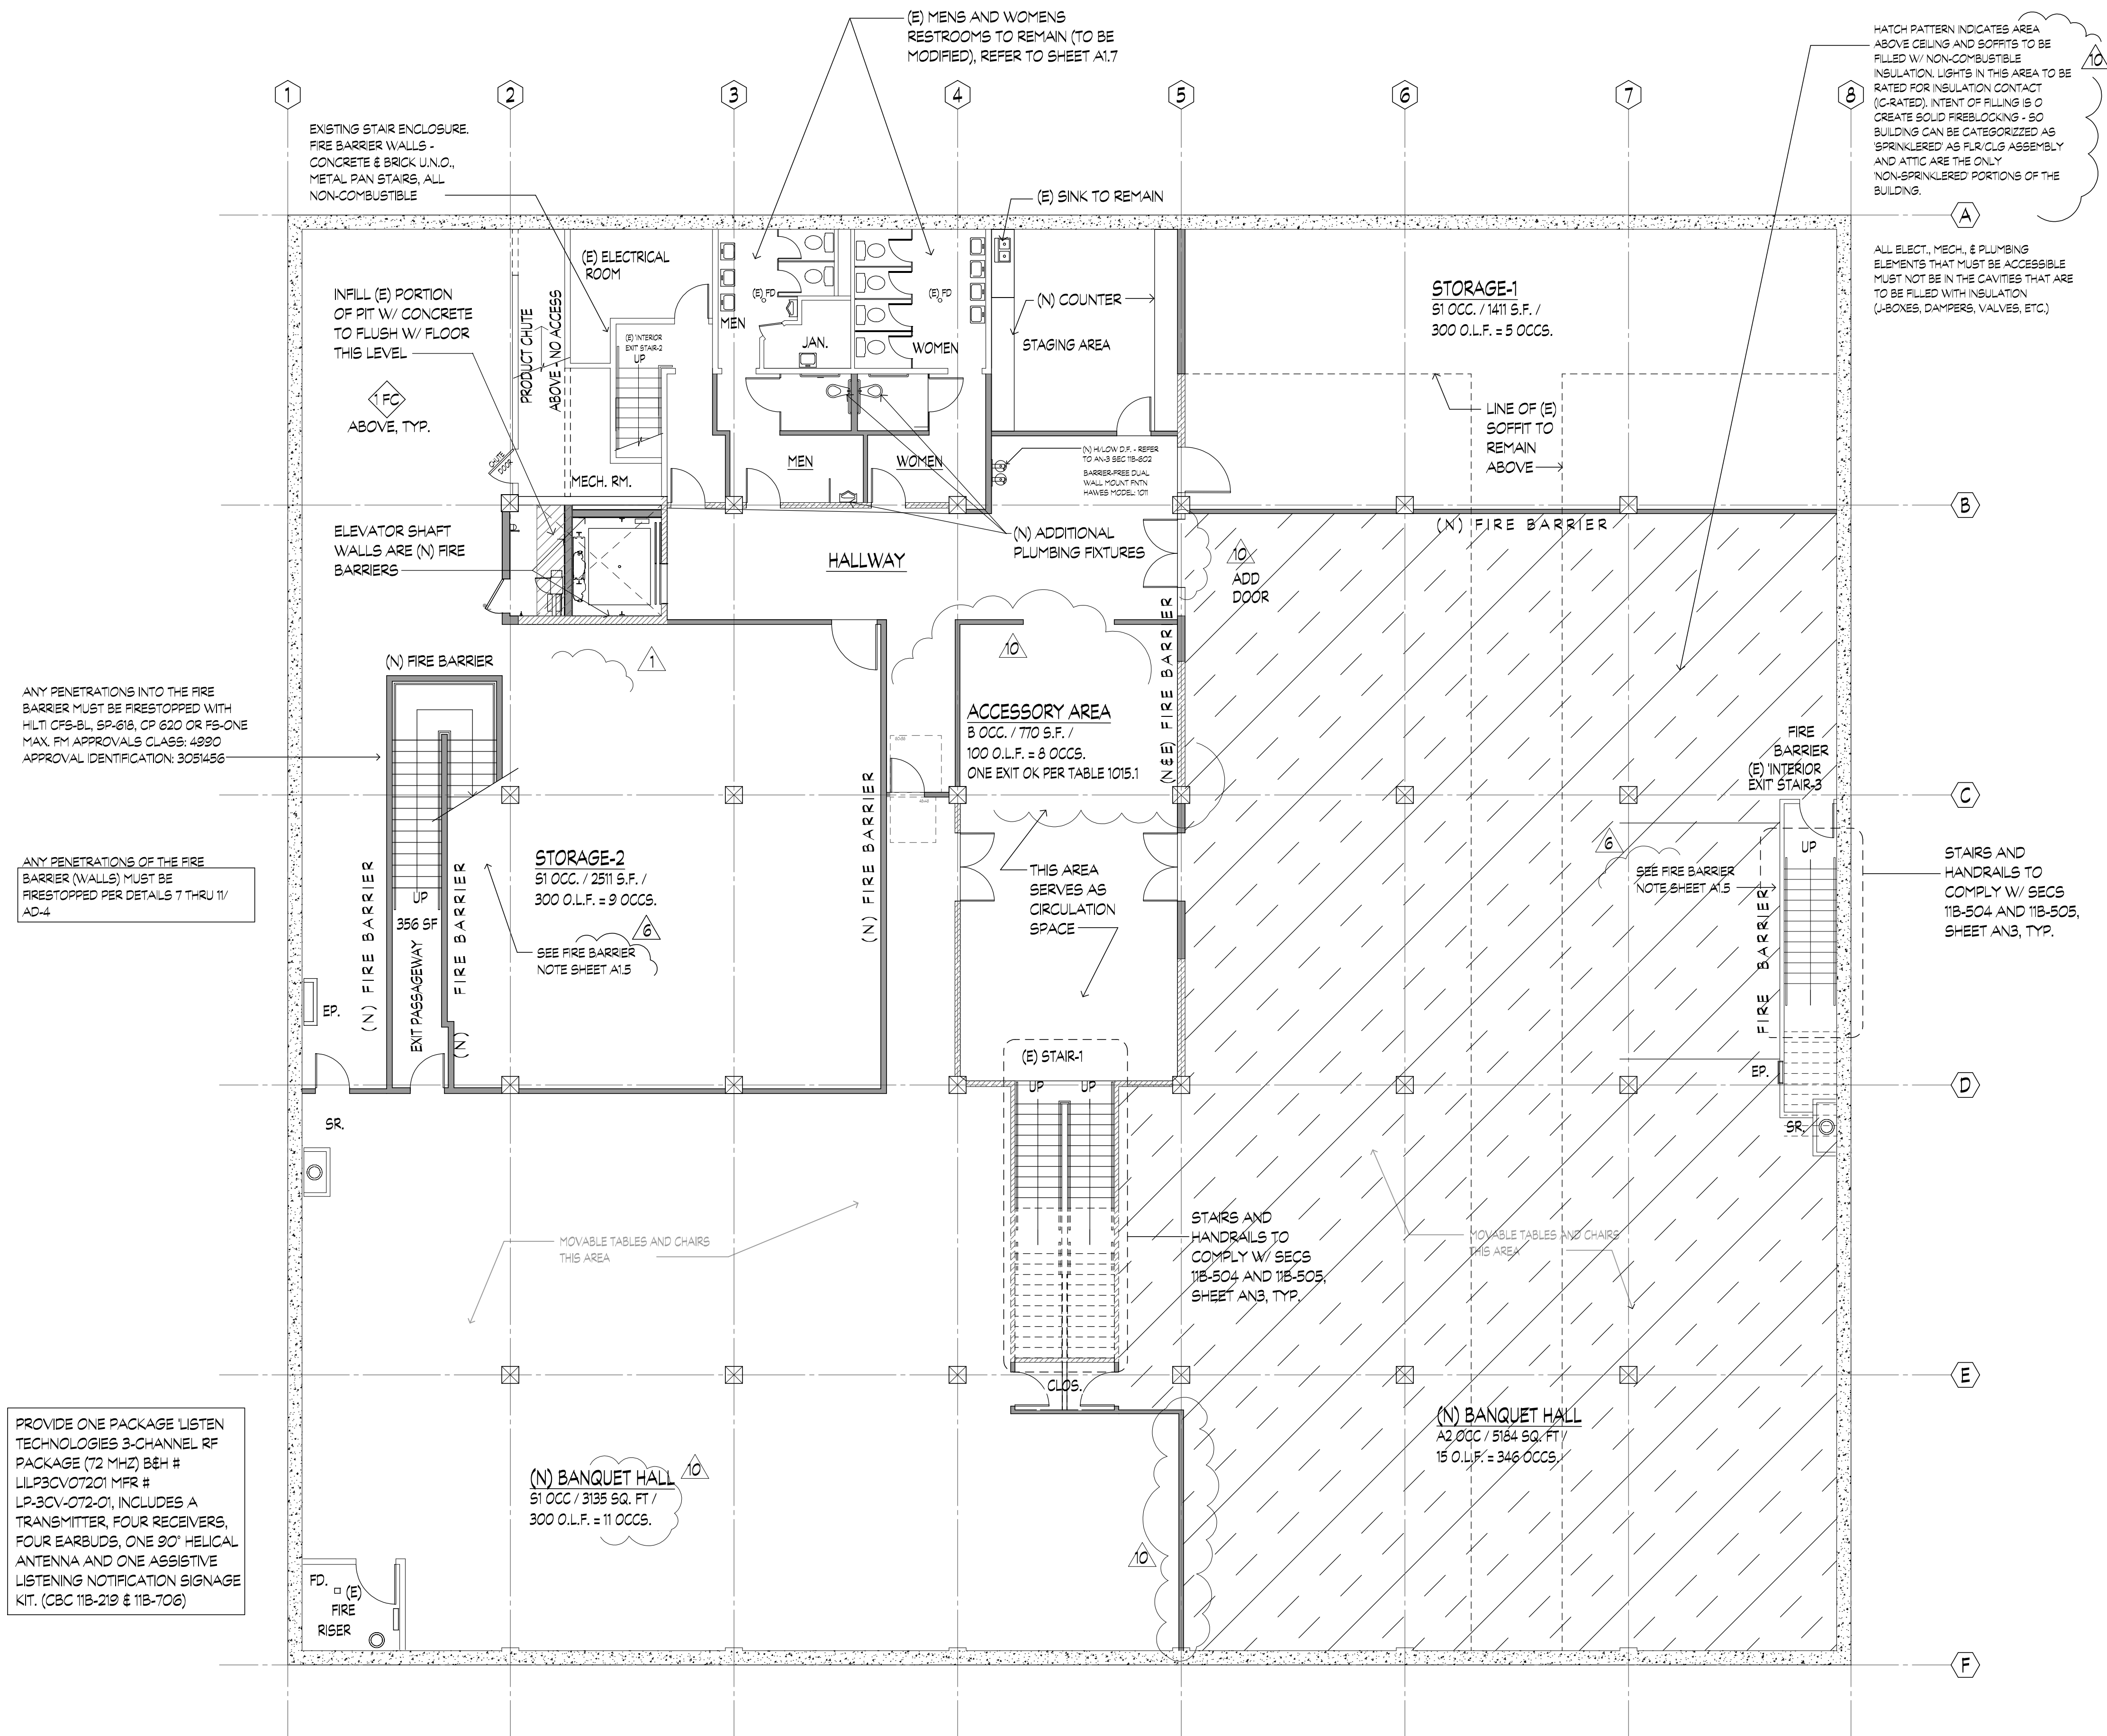


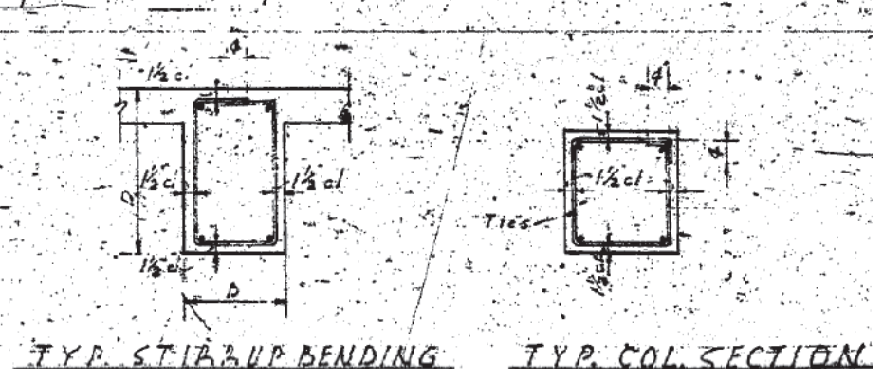


BASEMENT NEW FLOOR PLAN




(E) CONC. BEAM AND COLUMN, TYP. (TAKEN FROM ORIG. DRAWINGS)

FLOOR PLAN LEGEND

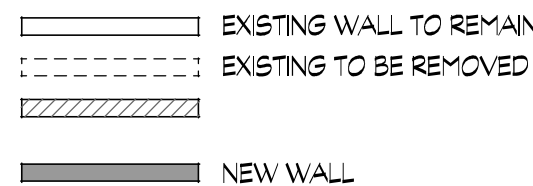


WALL LEGEND

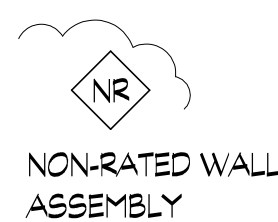


GA FILE NO. WP 3510	GENERIC	1 HOUR FIRE	35 TO 39 STC SOUND
GYPSUM WALLBOARD, WOOD STUDS			
One layer 1/2" type X gypsum wallboard or gypsum veneer base applied parallel or at right angles to each side of 2 x 4 wood studs 24" o.c. with 6d coated nails, 1 1/4" long, 0.09107 shank, 1/4" heads, 7" o.c. Joints staggered 24" on opposite sides. (LOAD-BEARING)			


Thickness: 47/8"	47/8"
Approx. Weight: 7 psf	UL R3501-47, -48, 9-17-65
Fire Test: OF	UL R3510-120, 7-22-70, UL Design U314
Sound Test: NSC 2-04, 10-14-73	

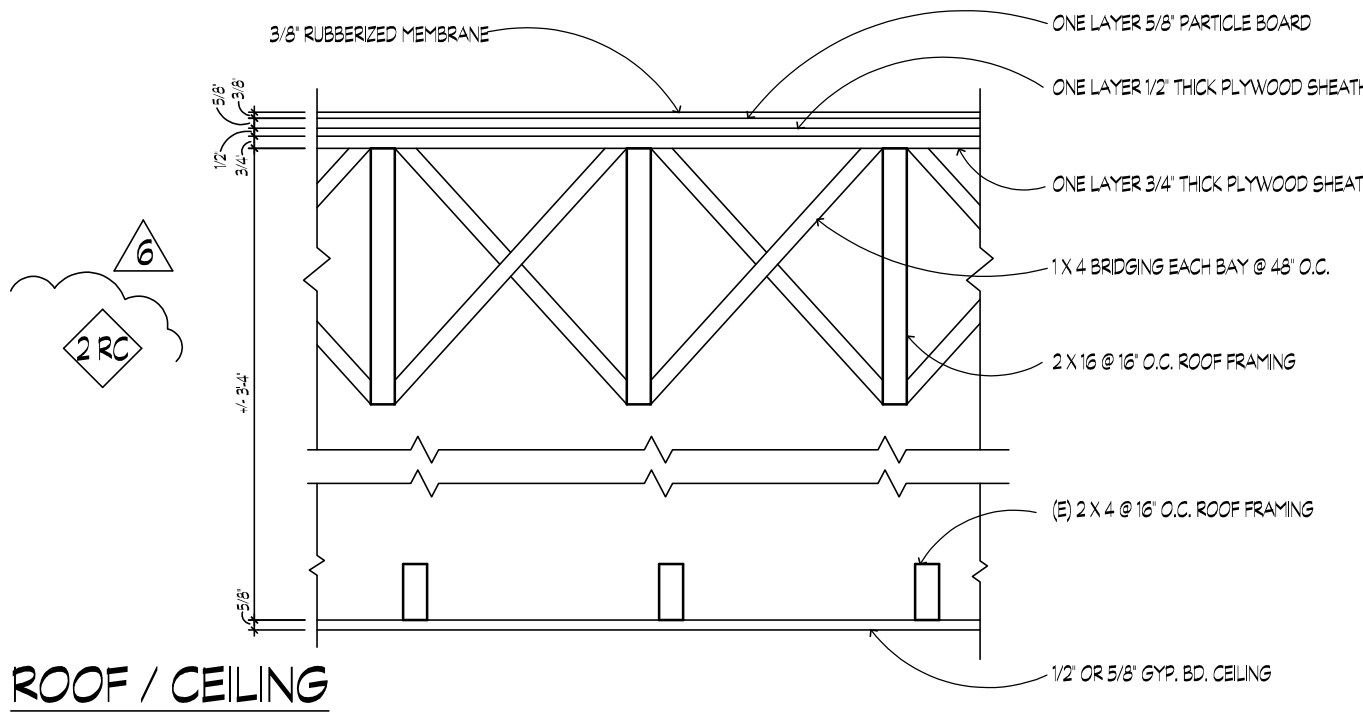

ROOF / CEILING

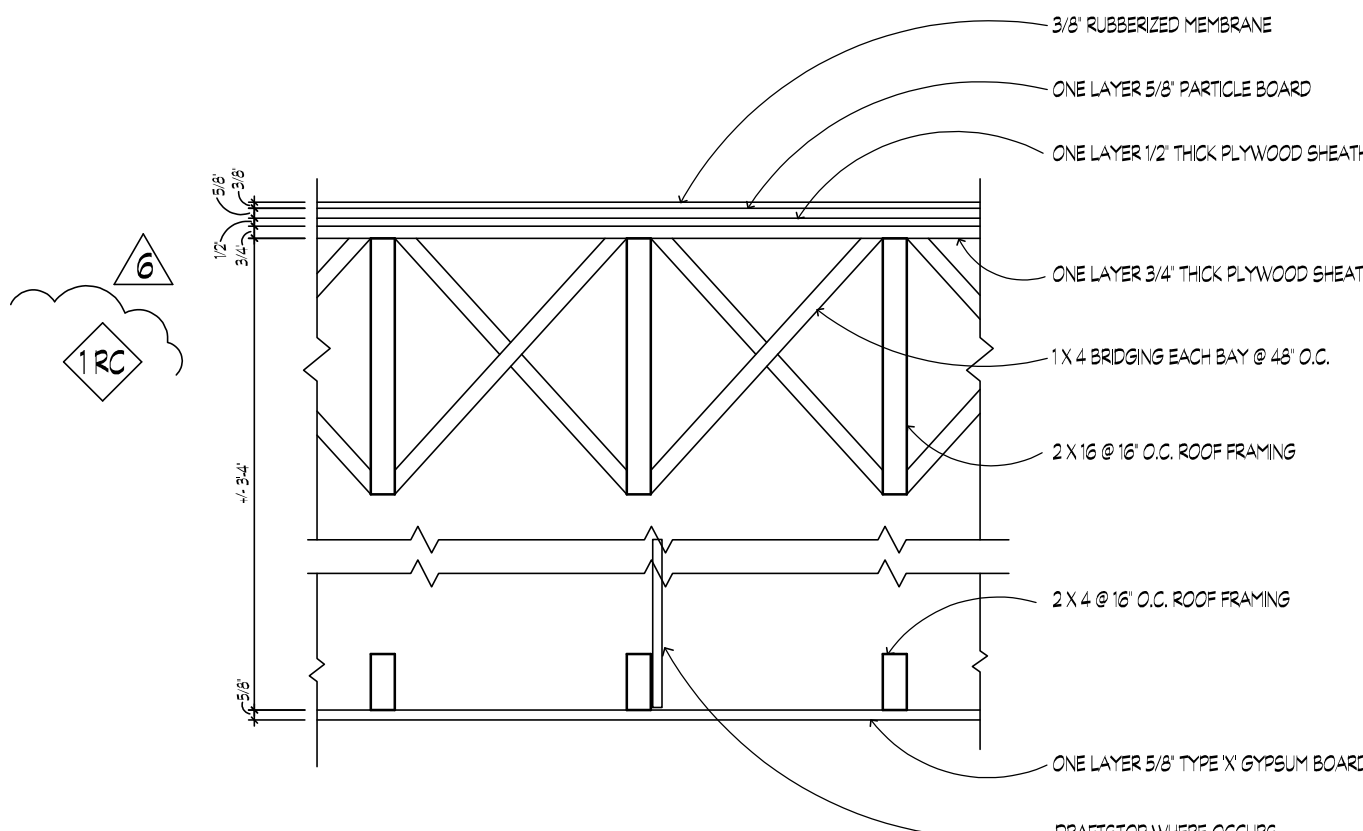


ROOF / CEILING (EXISTING COND.)

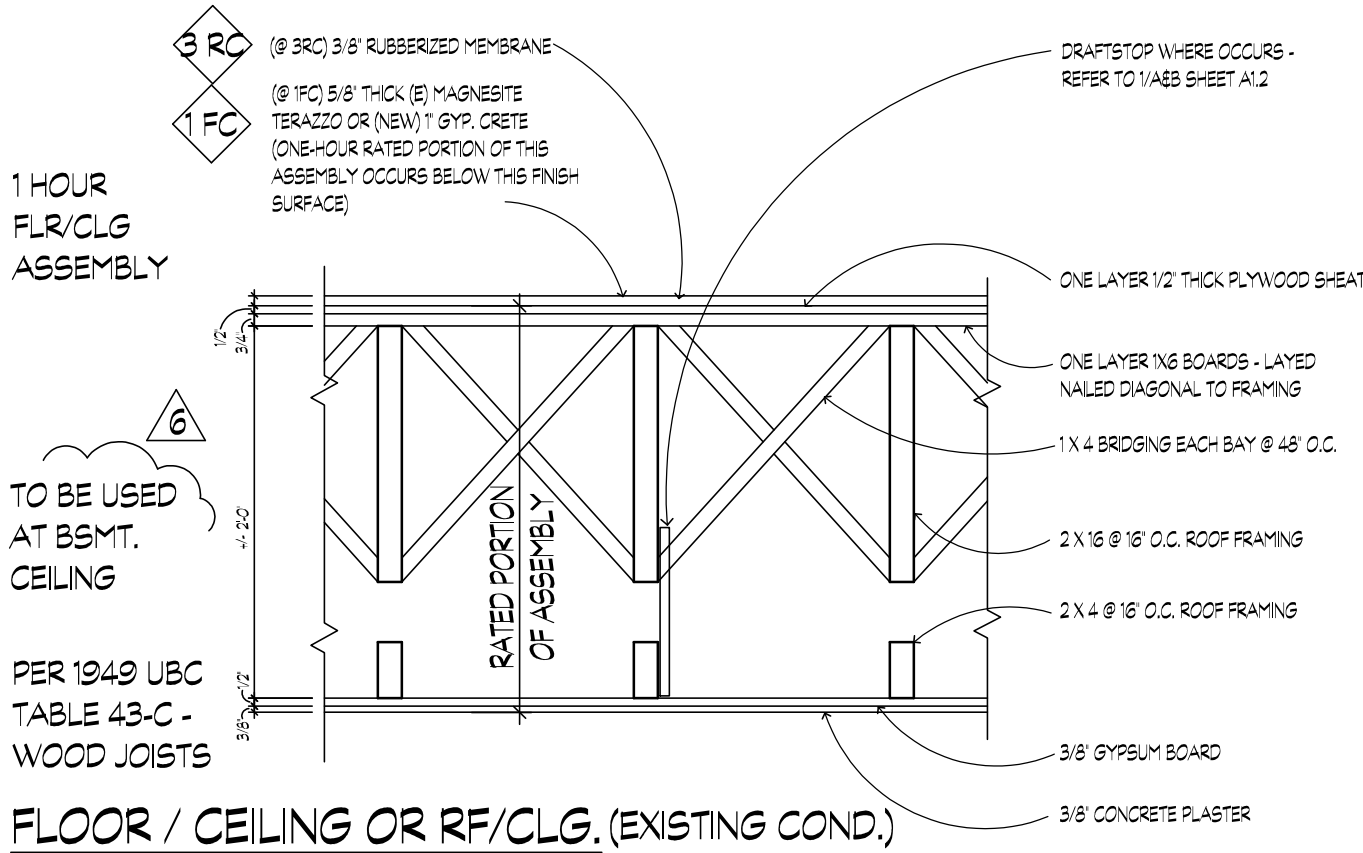

FLOOR / CEILING OR RF/CLG. (EXISTING COND.)

ron mitteveen
architect20032 e. santiago canyon road
orange, ca. 92869
ron @ ws-arc.com
(714) 642-3248

The Architect owns all copyrights to the Plan and derivatives which are subject to Federal copyright protection under the Architectural Works Copyright Protection Act of 1990. Unauthorized use or duplication of the Plan is a violation of Federal Laws and may result in punitive damages. The one-time-right to build this plan does not extend to others beyond the original purchaser.

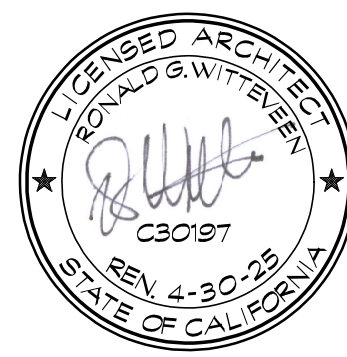Grand Central Plaza Mall
317 N Euclid Ave. Ontario, Ca 91762
Banquet Hall Tenant Improvementexpired
PCUP16-011

DATE OF THIS PLOT: 12/12/2024

REVISION: DATE:

1	
2	FIRE/PLNG/BLDG CORRS 07/01/2017
6	BLDG CORRS 06/04/2018
10	FIRE DEPT. 04/28/2019


 
BASEMENT
NEW FLOOR
PLAN

SHEET NUMBER

A1.1



FIRST FLOOR NEW FLOOR PLAN

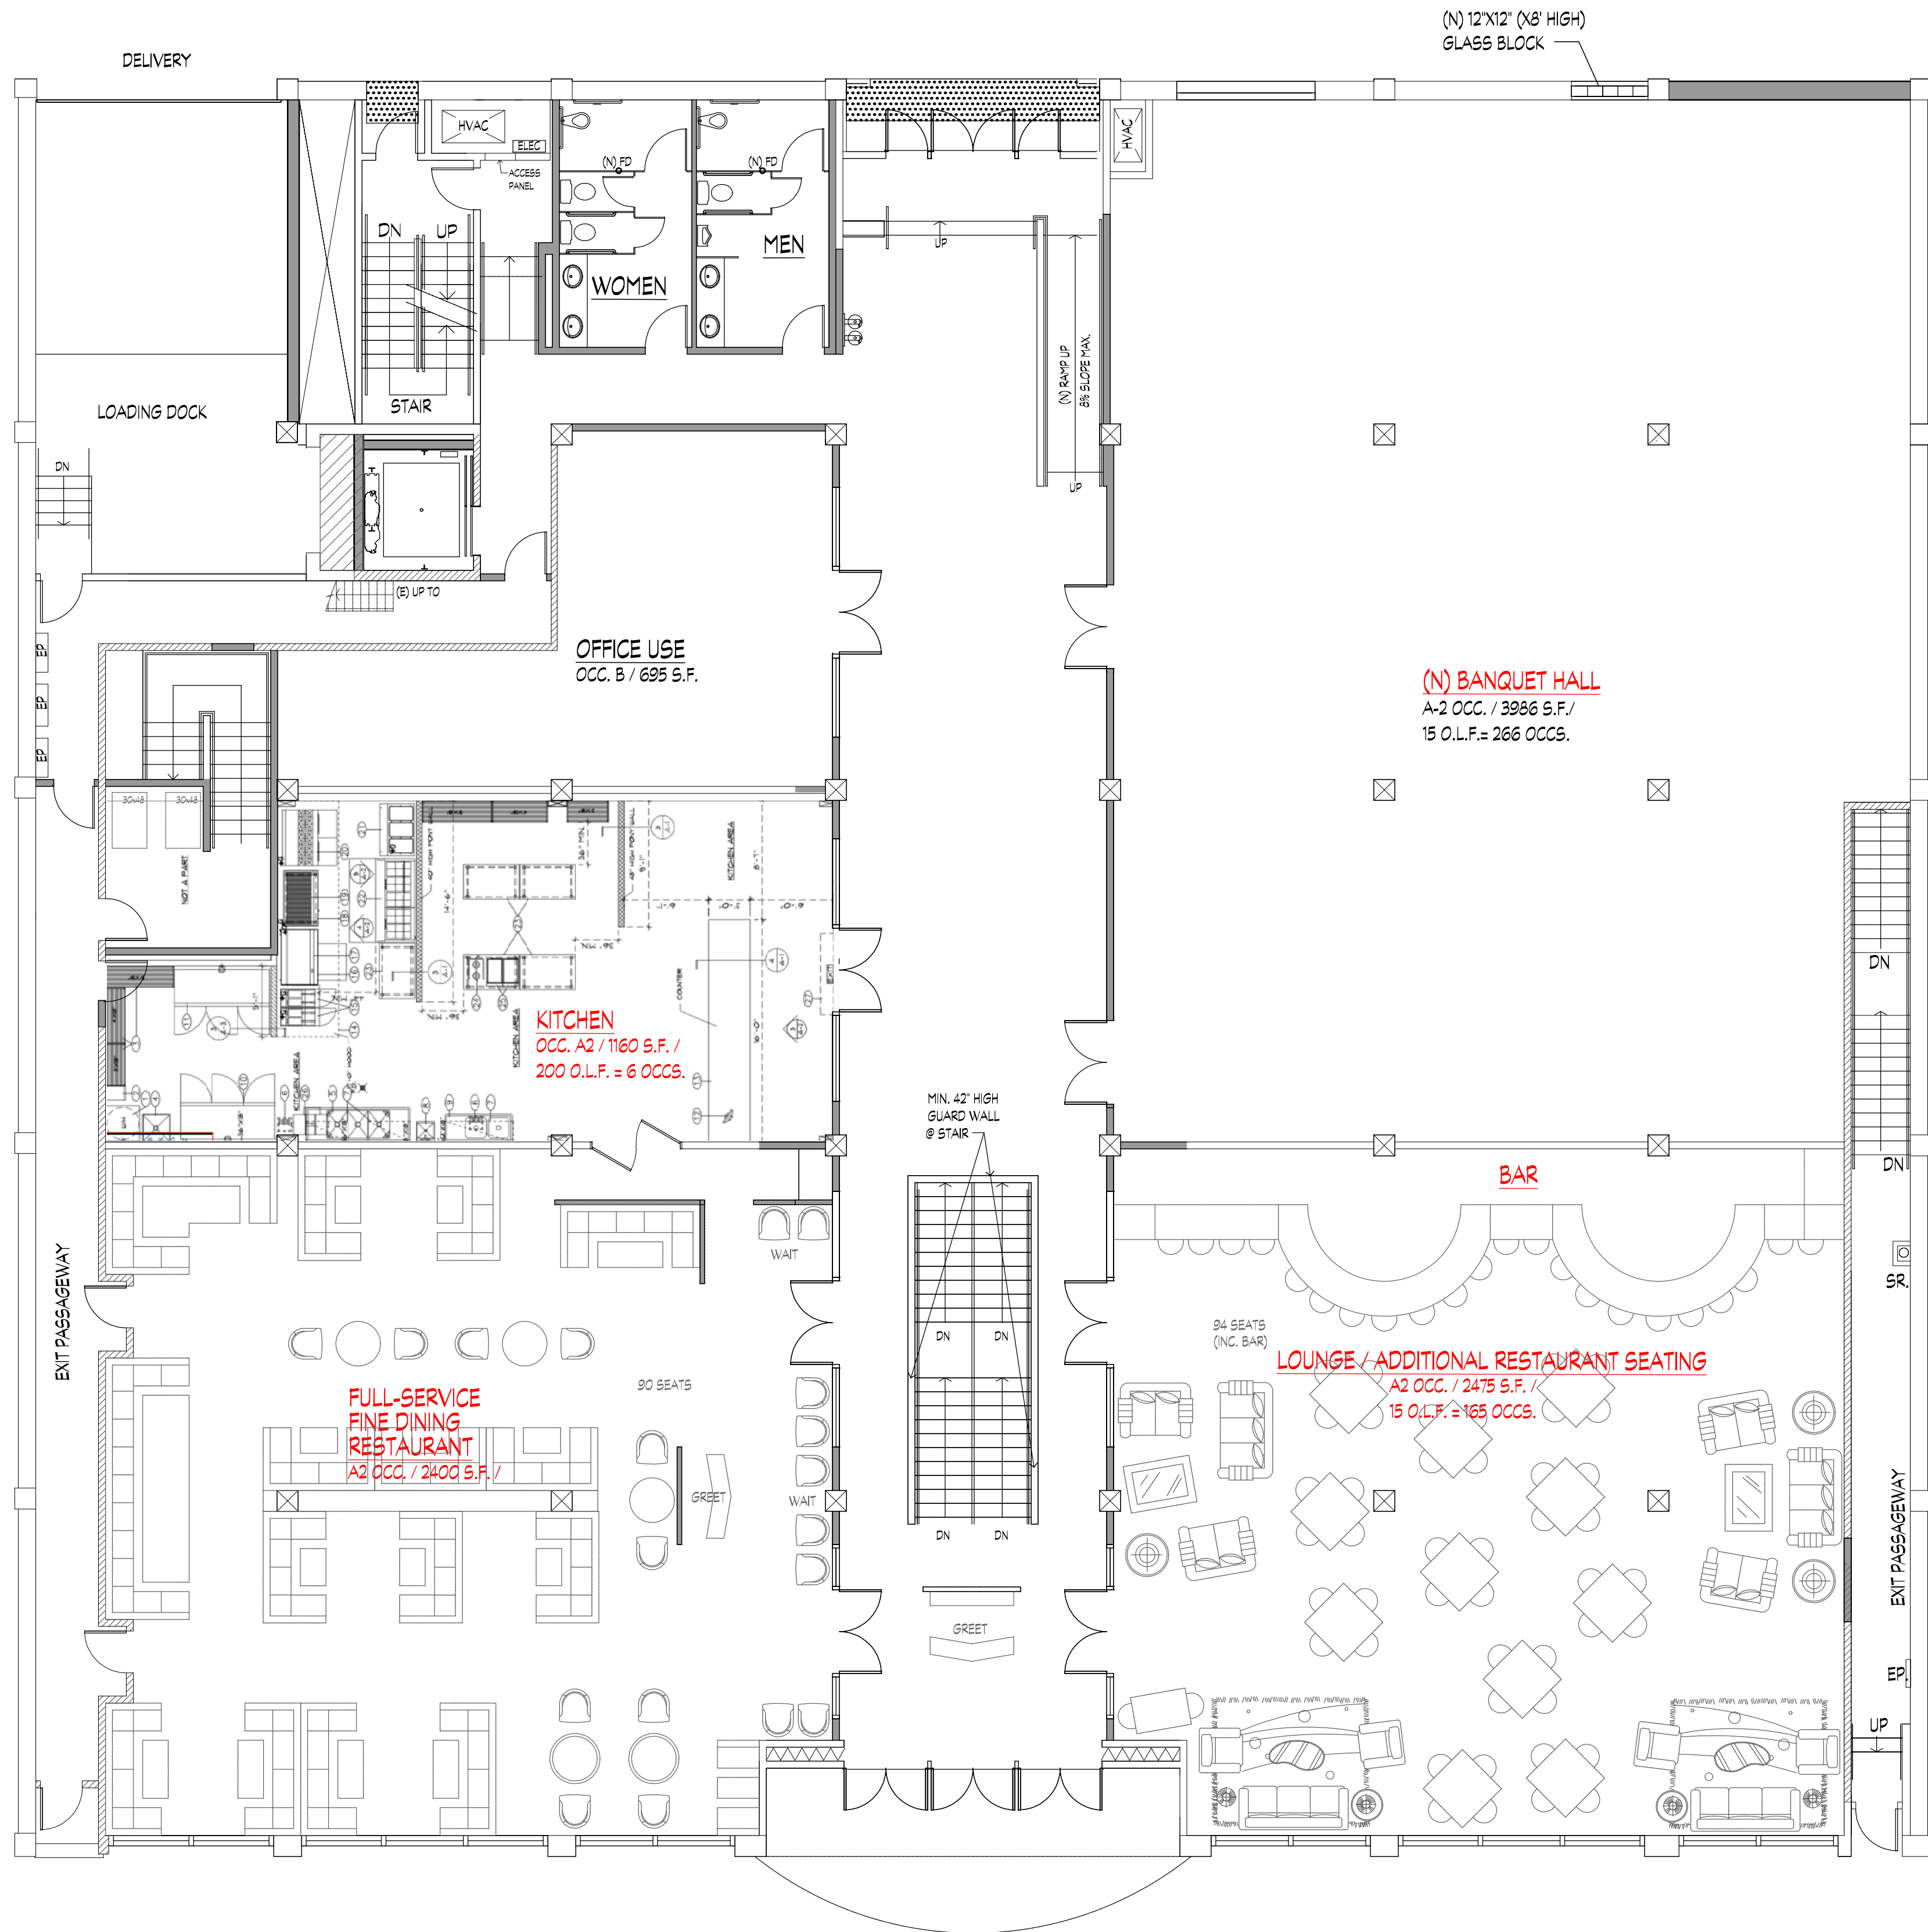

707.3.2 INTERIOR EXIT STAIRWAY AND RAMP CONSTRUCTION. THE FIRE-RESISTANCE RATING OF THE FIRE BARRIER SEPARATING BUILDING AREAS FROM AN INTERIOR EXIT STAIRWAY OR RAMP SHALL COMPLY WITH SECTION 1022.1. (ONE-HOUR)

707.3.3 ENCLOSURES FOR EXIT ACCESS STAIRWAYS. THE FIRE-RESISTANCE RATING OF THE FIRE BARRIER SEPARATING BUILDING AREAS FROM AN EXIT ACCESS STAIRWAY OR RAMP SHALL COMPLY WITH SECTION 1009.3.1.2. (ONE-HOUR)

707.3.4 EXIT PASSAGEWAY. THE FIRE-RESISTANCE RATING OF THE FIRE BARRIER SEPARATING BUILDING AREAS FROM AN EXIT PASSAGEWAY SHALL COMPLY WITH SECTION 1023.3. (ONE-HOUR)

FLOOR PLAN LEGEND

— EXISTING WALL TO REMAIN
--- EXISTING TO BE REMOVED
— NEW WALL

E.P. ELECTRICAL PANEL
S.R. SPRINKLER RISER
F.D. FLOOR DRAIN
NR WALL ASSEMBLY MAY BE NON-RATED (USE SAME ASSEMBLY AS 1W)

WALL LEGEND




NON-RATED WALL
ASSEMBLY

ONE LAYER 5/8" GYPSUM BOARD APPLIED PARALLEL
OR AT RIGHT ANGLES APPLIED TO EACH SIDE OF 2x4
WOOD STUDS @ 24" O.C. W/ 6 NAILS 1 1/8" LONG,
0.0915" SHANK, 1/4" HEADS @ 7" O.C.

JOINTS STAGGERED 24" ON OPPOSITE
SIDES (LOAD-BEARING)

1 HOUR
WALL
ASSEMBLY


GA FILE NO. WP 3510	GENERIC	1 HOUR FIRE	35 to 39 STC SOUND
GYPSUM WALLBOARD, WOOD STUDS			
One layer 1/2" type X gypsum wallboard or gypsum veneer base applied parallel or at right angles to each side of 2 x 4 wood studs 24" o.c. with 6d coated nails, 1 1/4" long, 0.0915" shank, 1/4" heads, 7" o.c.			
JOINTS STAGGERED 24" ON OPPOSITE SIDES (LOAD-BEARING)			
		Thickness: 47/8"	
		Approx. Weight: 7 psf	
		Fire Test: UL R3501-47, -48, 9-17-65; UL R3515-123, 7-22-70; UL Design U314	
		Sound Test: NSC 2-04, 10-14-73	

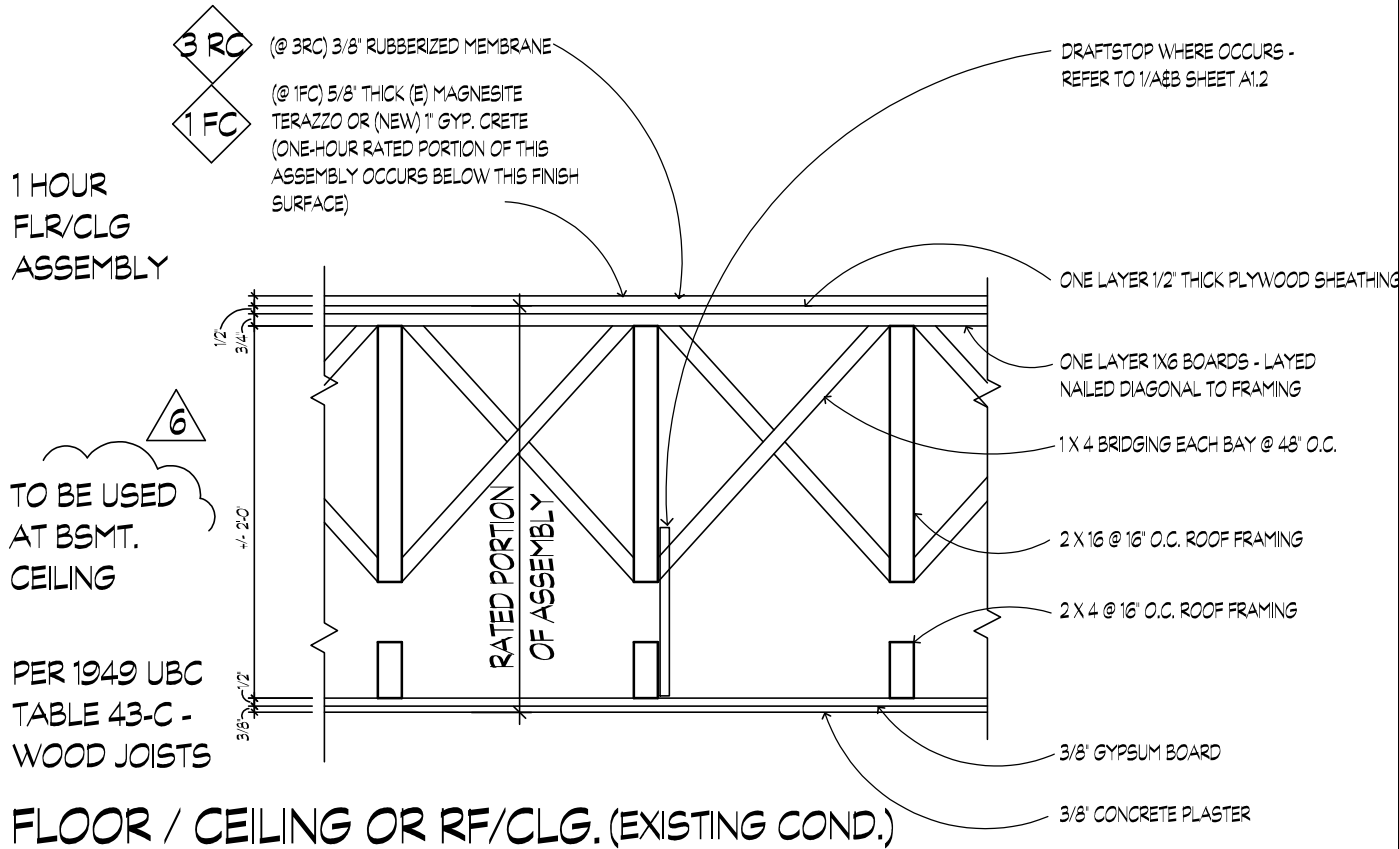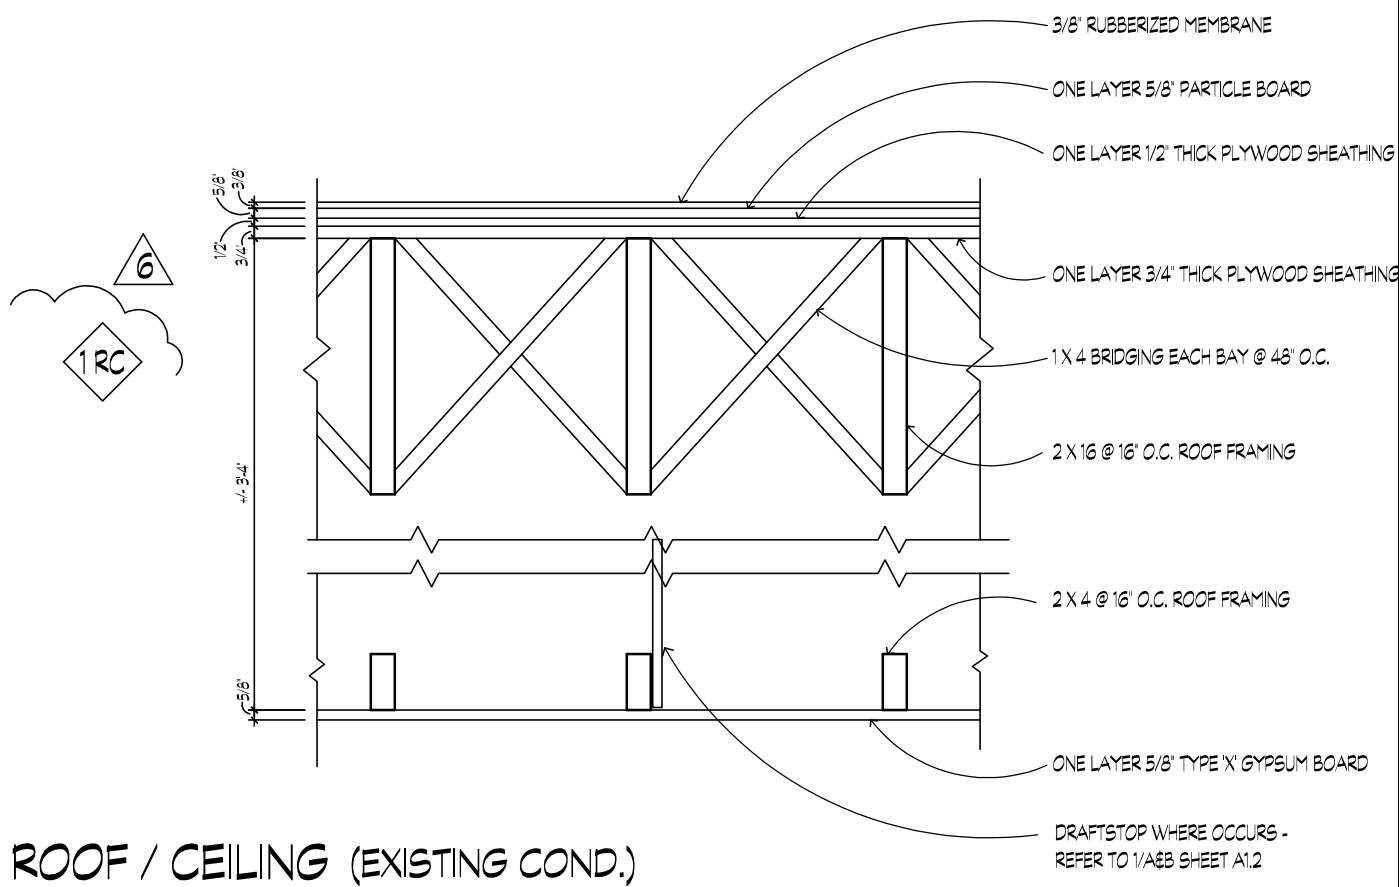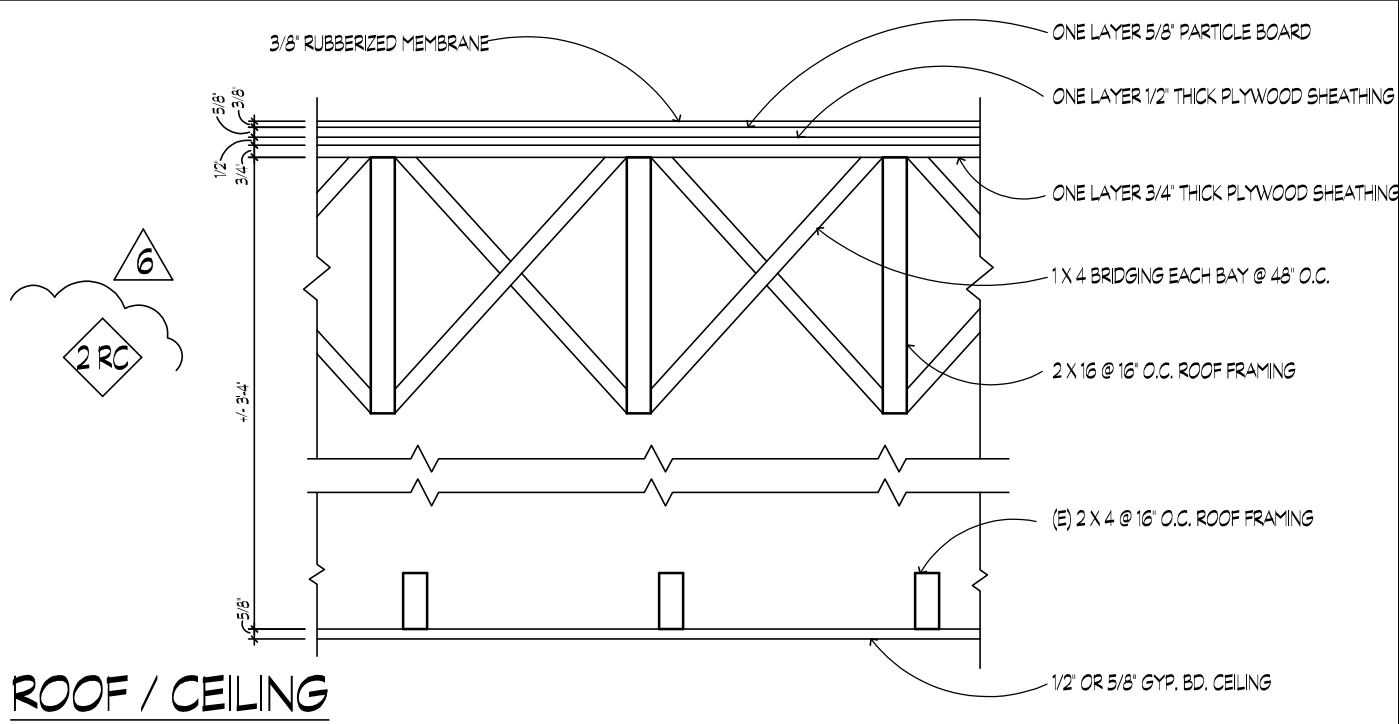

ra

ron mitteveen
architect20032 e. santiago canyon road
orange, ca. 92869
ron @ ws-arc.com
(714) 642-3248

The Architect owns all copyrights to the Plan and derivatives which are subject to Federal copyright protection under the Architectural Works Copyright Protection Act of 1990. Unauthorized use or duplication of the Plan is a violation of Federal Laws and may result in punitive damages. The one-time-right to build this plan does not extend to others beyond the original purchaser.

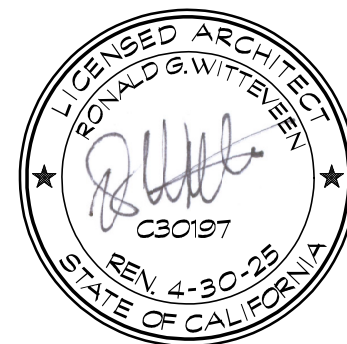Grand Central Plaza Mall
317 N Euclid Ave. Ontario, Ca 91762
Banquet Hall Tenant Improvementexpired
PCUP16-011

DATE OF THIS PLOT: 12/12/2024

REVISION: DATE:

△	
△	
△	
△	
△	
△	
△	
△	

FIRST FLOOR
KITCHEN / REST.
PLAN

SHEET NUMBER

A1.5